
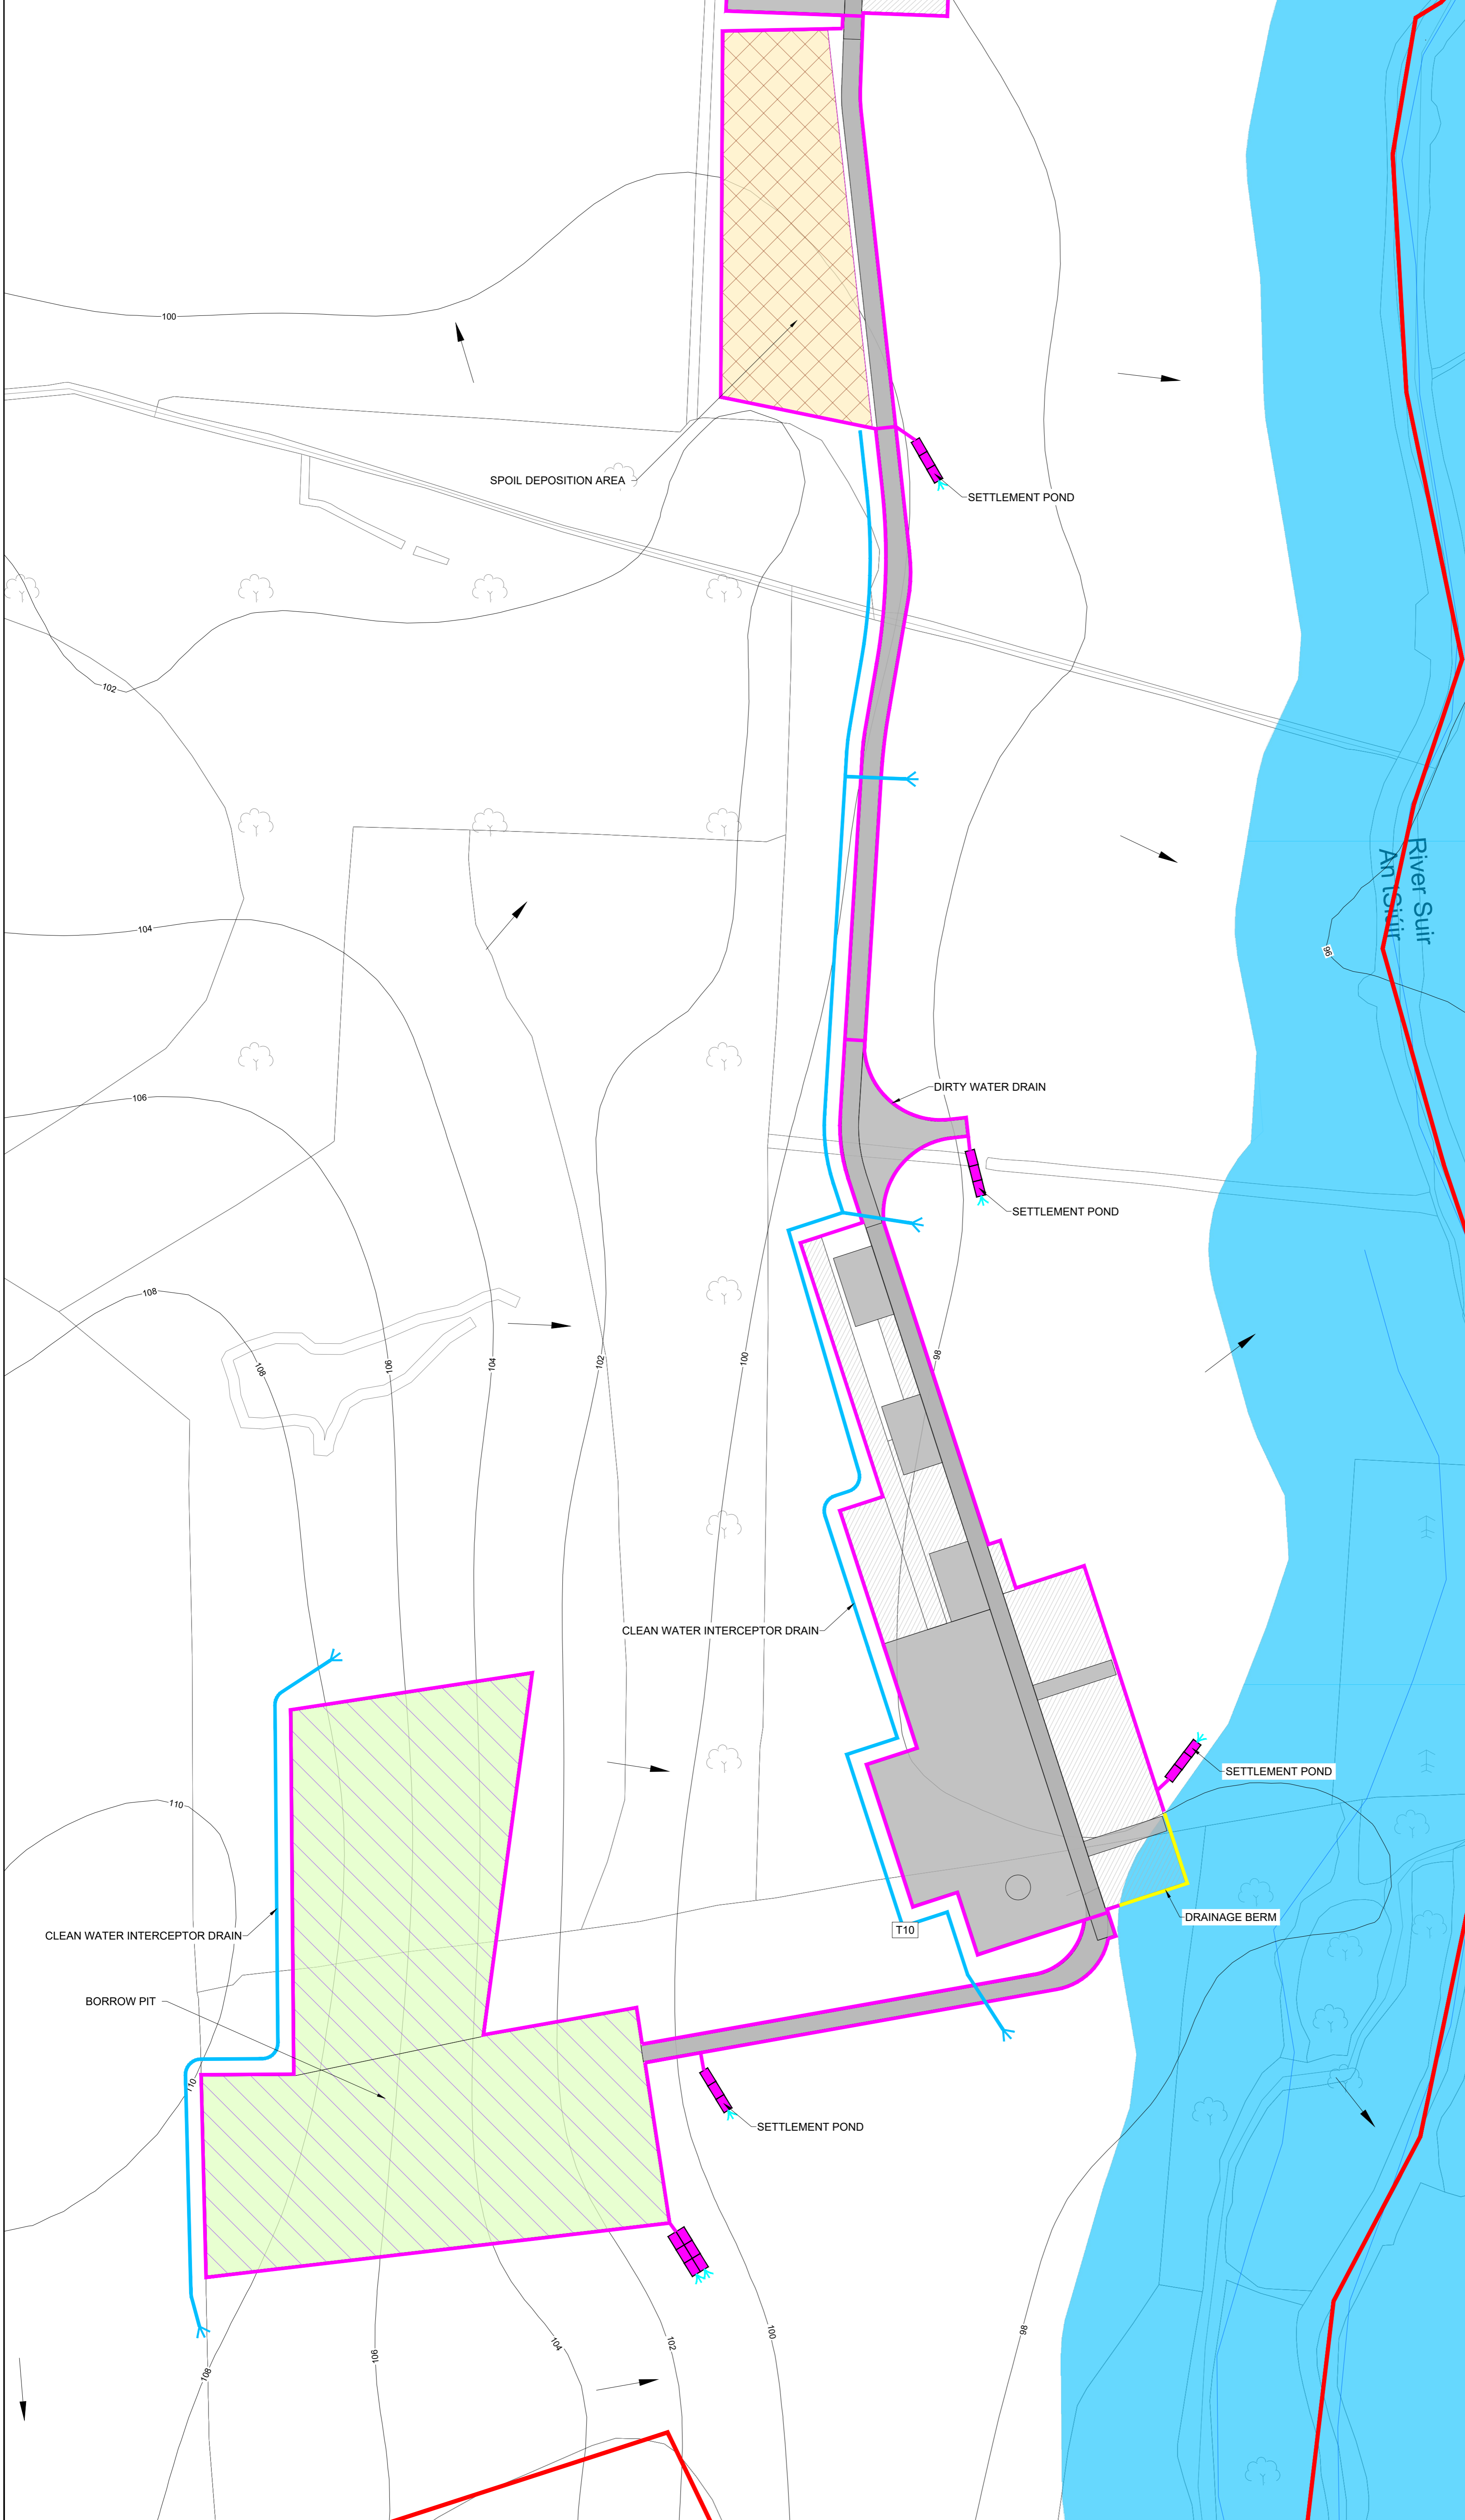


DO NOT SCALE FROM THIS DRAWING. USE FIGURED DIMENSIONS IN ALL CASES. VERIFY DIMENSIONS ON SITE AND REPORT ANY DISCREPANCIES TO THE DESIGNERS IMMEDIATELY. THIS DRAWING IS COPYRIGHT AND MAY ONLY BE REPRODUCED WITH THE DESIGNERS PERMISSION.

- NOTES:**
1. ALL DRAWINGS ARE TO BE READ IN CONJUNCTION WITH ALL RELEVANT SPECIFICATIONS, BILLS OF QUANTITIES, ARCHITECTURAL, SERVICES AND ENGINEERING DRAWINGS.
 2. ALL LEVELS ARE IN METRES RELATED TO ORDNANCE DATUM MALIN HEAD.
 3. ANY DISCREPANCIES BETWEEN THESE DOCUMENTS SHALL BE BROUGHT TO THE ATTENTION OF THE ENGINEER.
 4. DRAWINGS ARE NOT TO BE SCALED.
 5. ALL DIMENSIONS ARE IN MILLIMETRES, UNLESS NOTED OTHERWISE.

- LEGEND:**
- PLANNING BOUNDARY (EDGED IN RED)
 - TURBINE HARDSTAND
 - ACCESS TRACK
 - SPOIL DEPOSITION AREA
 - BORROW PIT
 - DIRTY WATER DRAIN
 - CLEAN WATER INTERCEPTOR DRAIN
 - DRAINAGE BERM
 - DIRTY WATER SETTLEMENT POND
 - STORM WATER DRAIN
 - WATERCOURSE
 - WATERCOURSE 50M BUFFER
 - SLOPE ARROW

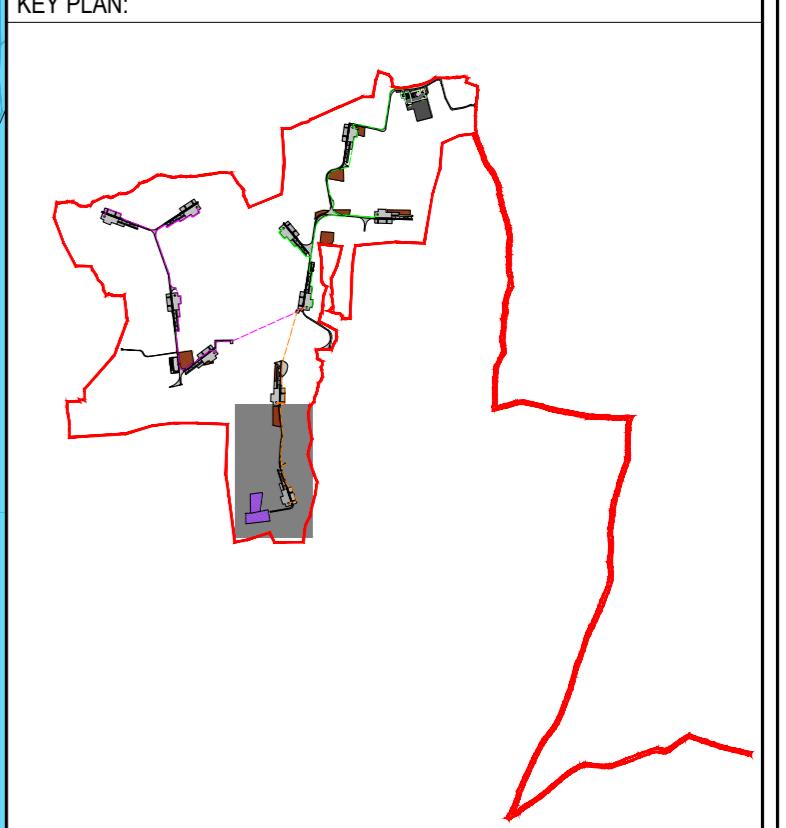

Map Reproduced From Tailte Éireann
By Permission Of The Government.
CYAL50332198

OSI SHEET NO:
4576-D, 4577, 4635-B, 4635-D, 4636, 4636-A,
4636-C, 4636-D, 4637, 4696-A, 4696-B & 4697-A

P01	15.11.24	Issued For Planning	JK	PC
REV	DATE	DESCRIPTION	BY	APP
PROJECT: BRITTAS WIND FARM				
TITLE: DRAINAGE LAYOUT - SHEET 4				
CLIENT: BRITTAS WIND FARM LTD.				
 ENGINEERING AND ENVIRONMENTAL CONSULTANTS CORK TRALEE LONDON LIMERICK mwp.ie				
DRAWN:	MV	CHECKED:	JK	APPROVED:
PROJECT NUMBER:	23318	DATE:	JUNE 2024	SCALE @ A1:
STATUS DESCRIPTION: FOR INFORMATION				STATUS: S2
DRAWING NUMBER:	23318 - MWP - 00 - 00 - DR - C - 5029			REV: P01